
 


MATCHLINE SHEET 1  
MATCHLINE SHEET 2

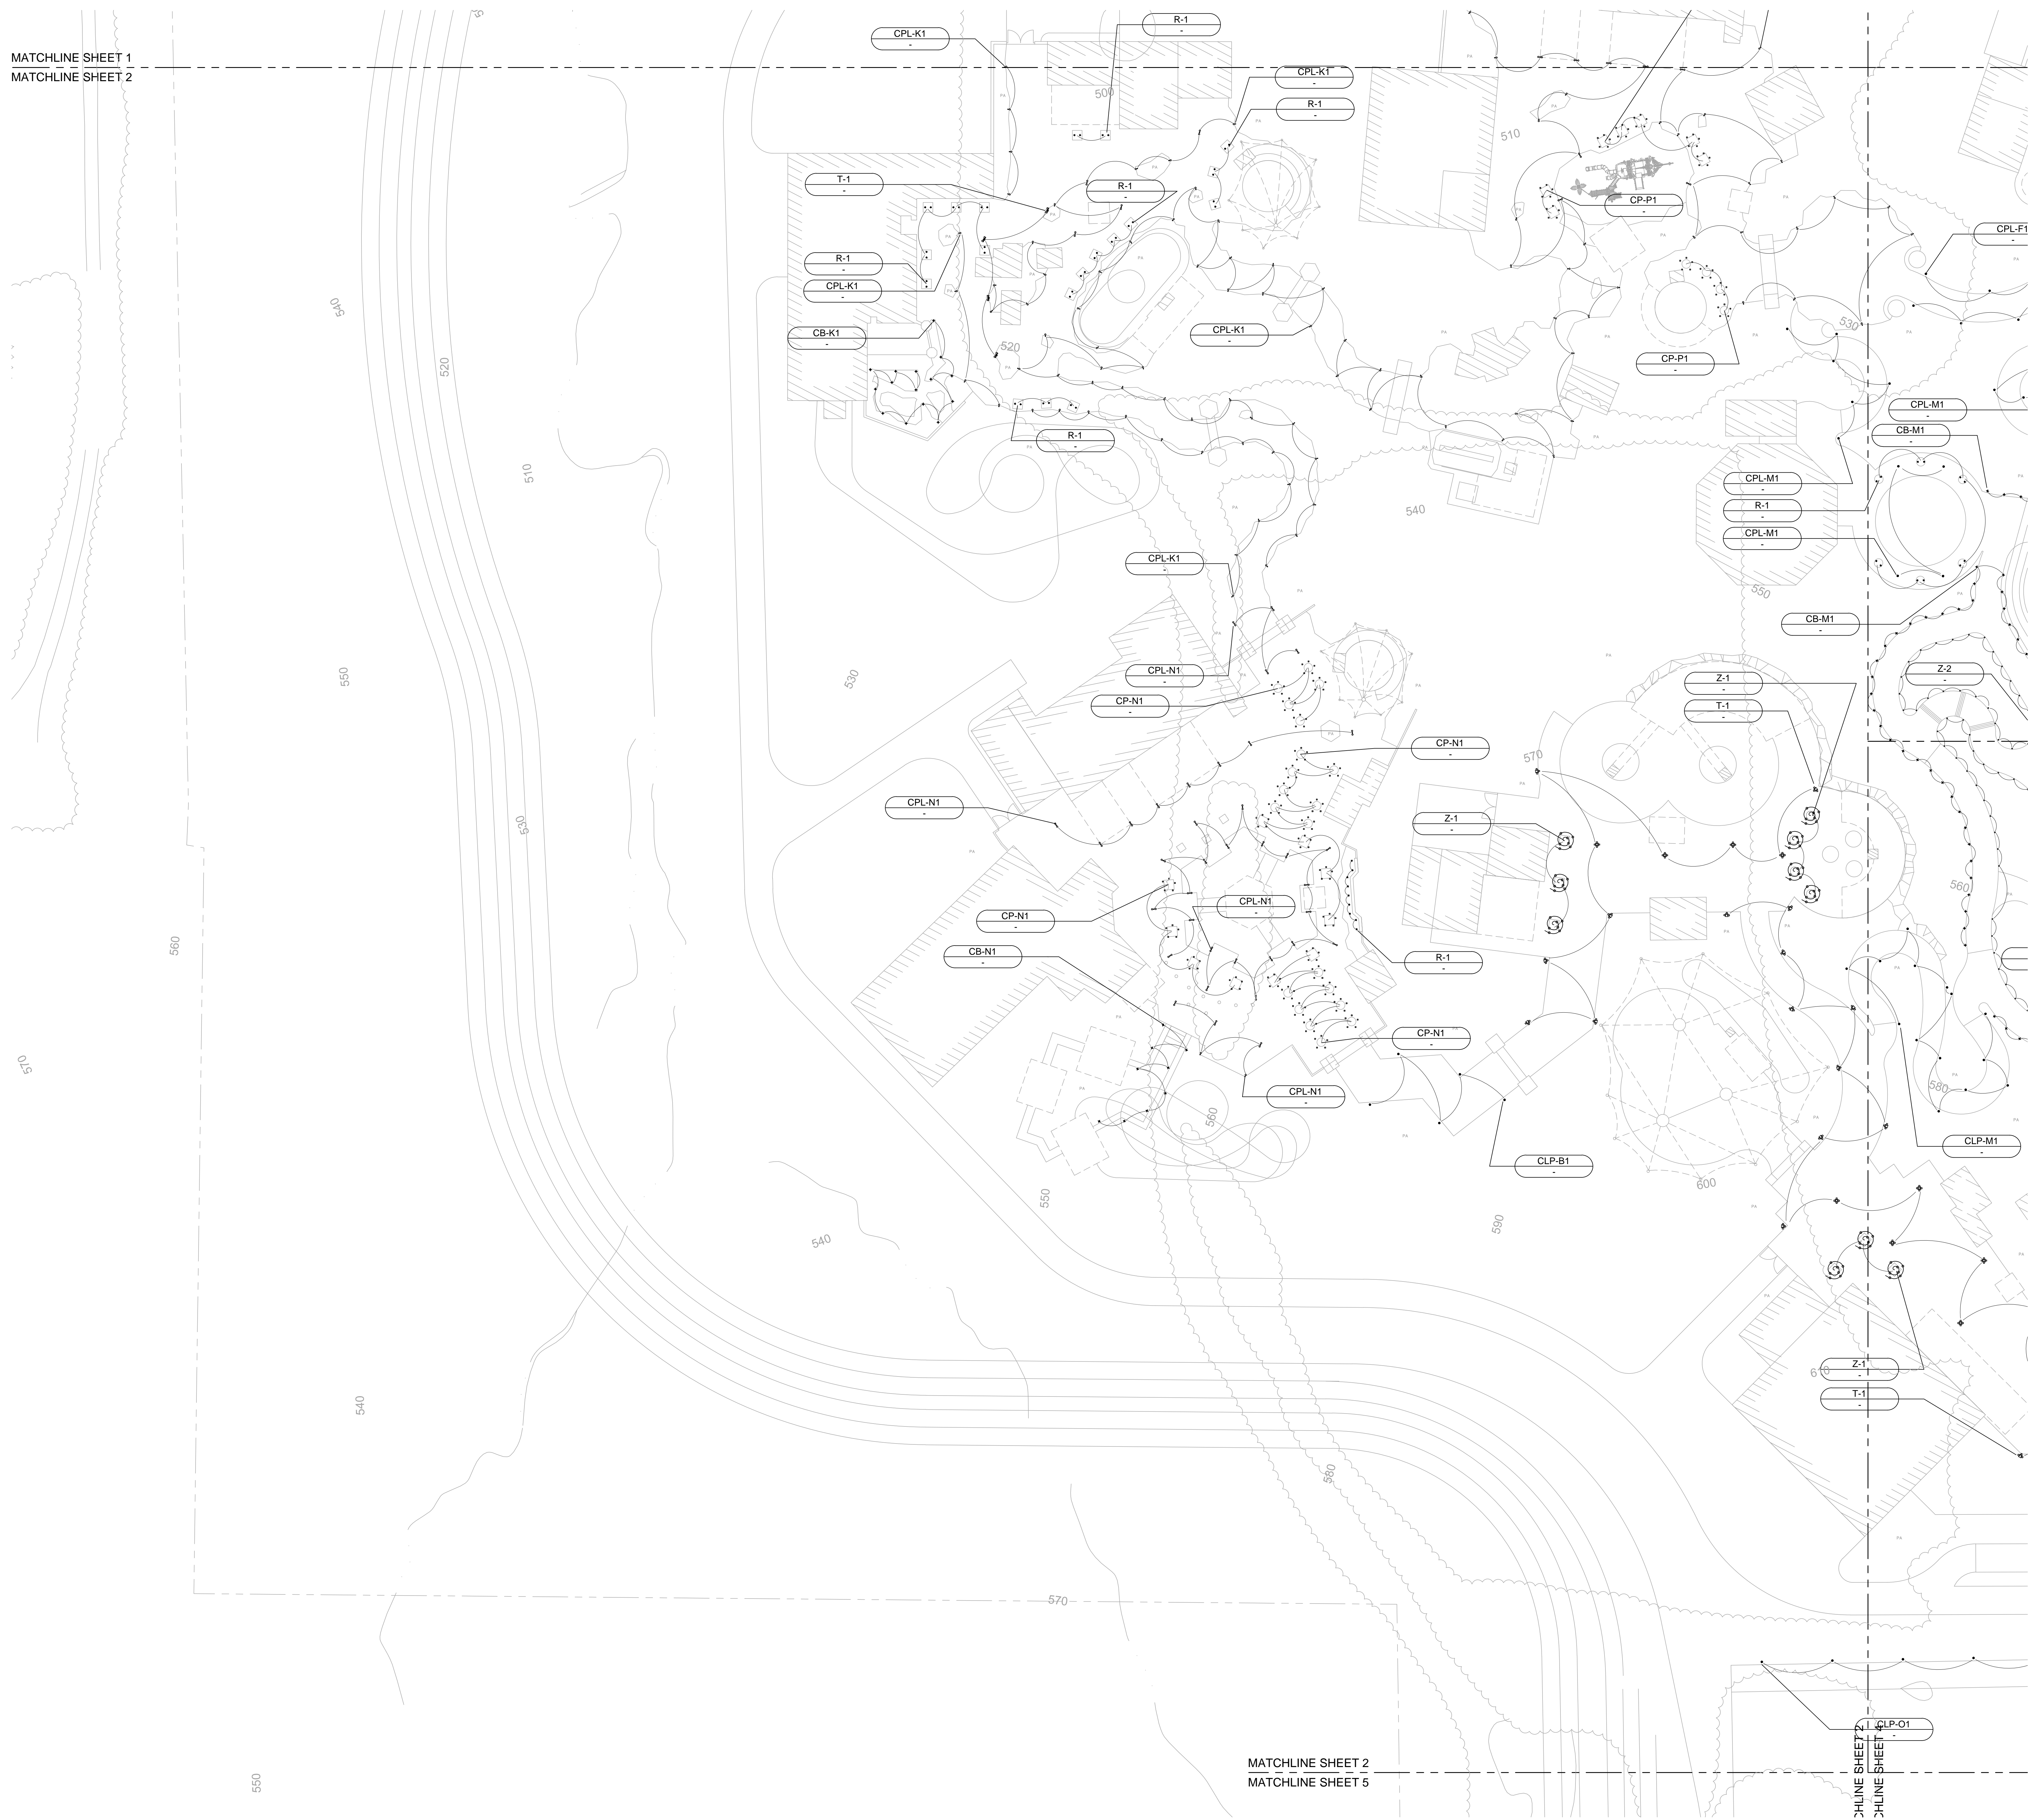


MATCHLINE SHEET 2  
MATCHLINE SHEET 5

MATCHLINE SHEET 2  
MATCHLINE SHEET 5



OVERALL KEYPLAN

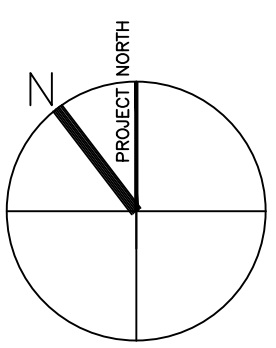

ISSUES		
Issue No.	Description	Issue Date

PARKWIDE  
AREA DEVELOPMENT  
LIGHTING PLAN

Scale: 1" = 40'  
Drawn By: LV/RJ  
Date: SEP. 1, 2016 | Project No: 5.15.3

Component | ID | Drawing Number

OS10000L192

ISSUED FOR INFORMATION ONLY, NOT FOR CONSTRUCTION